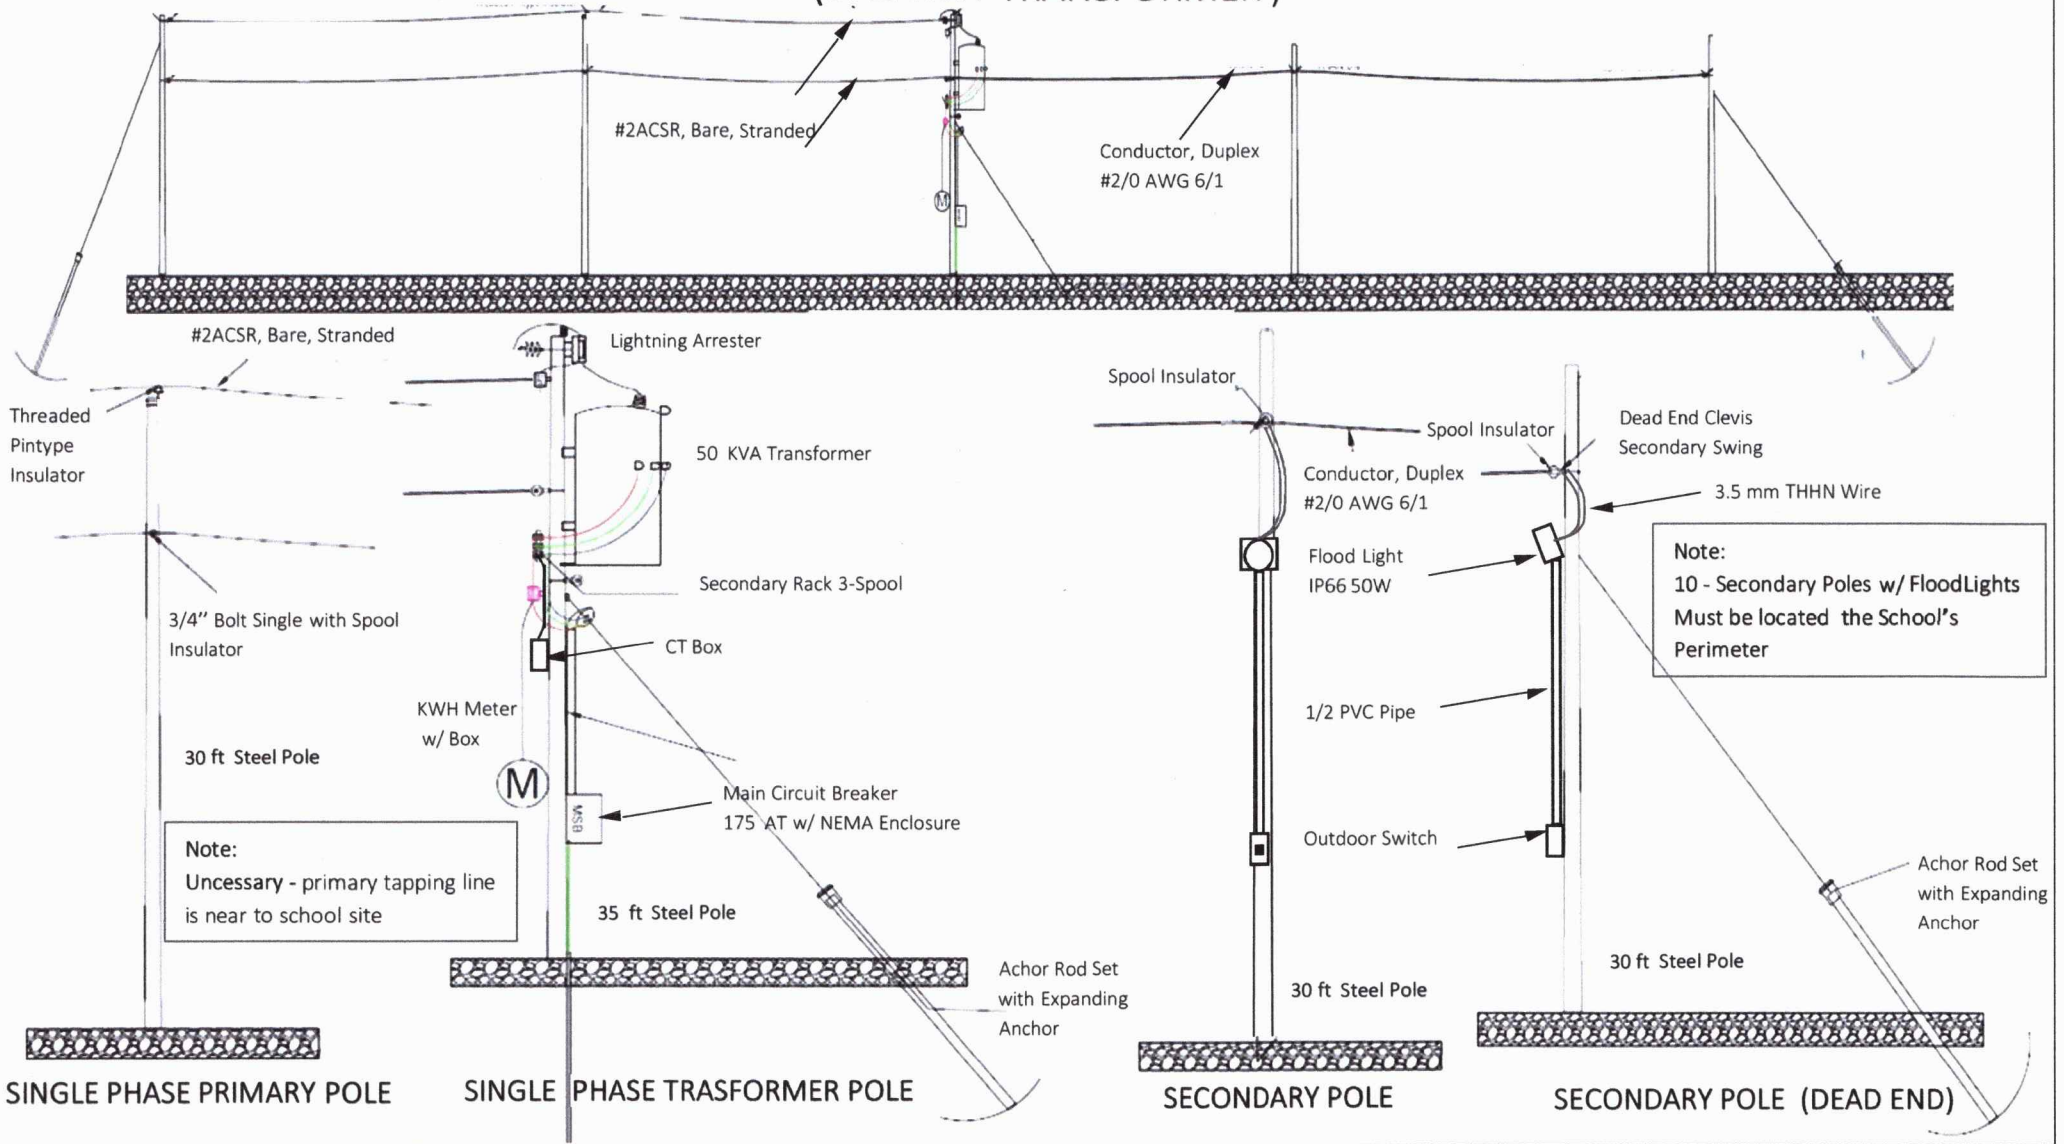

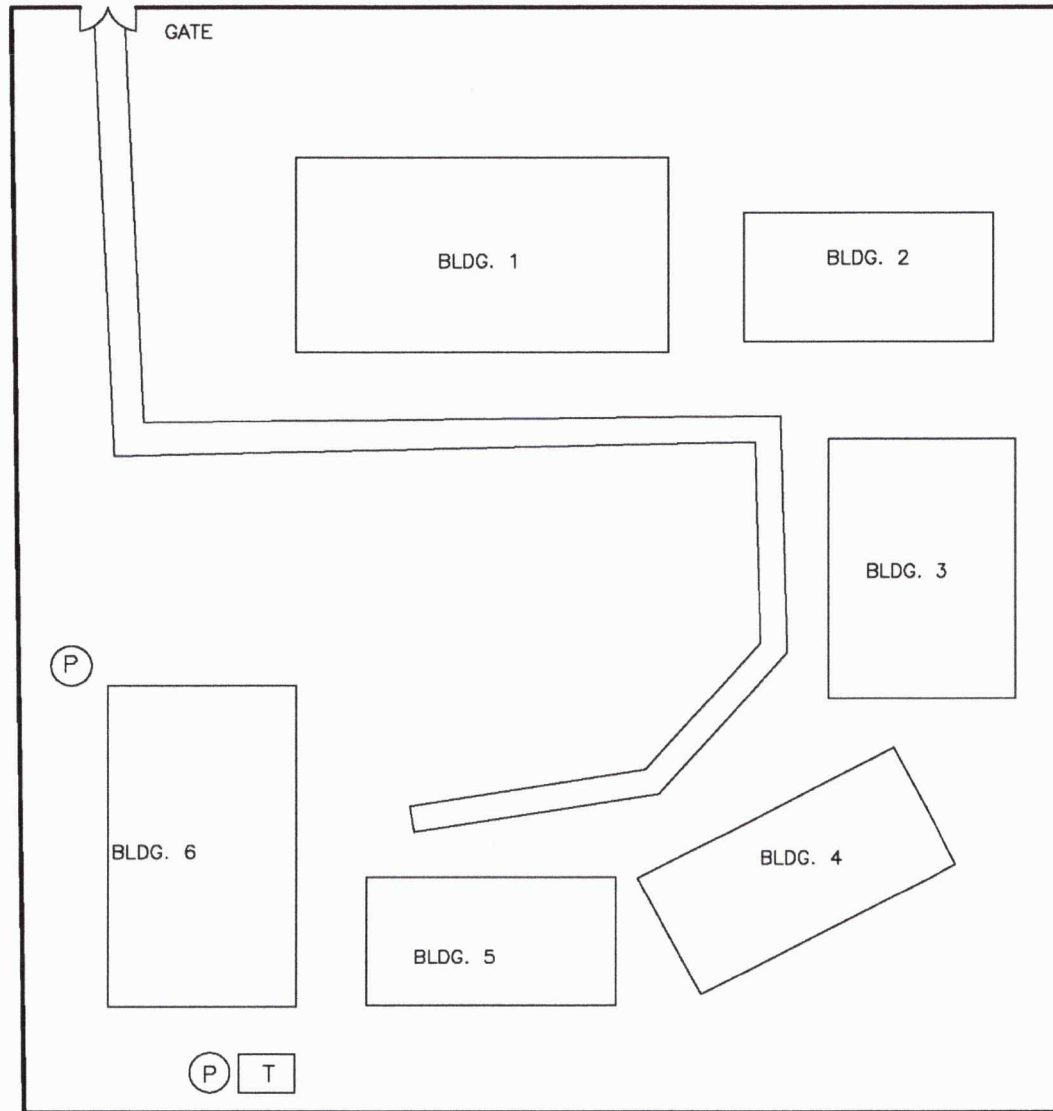


# OVERHEAD DISTRIBUTION SYSTEM (37.5 KVA TRANSFORMER)



 REPUBLIC OF THE PHILIPPINES DEPARTMENT OF EDUCATION CARAGA REGION	PREPARED BY:	REC. APPROVAL:	APPROVED BY:	CONCURRED BY:	PROJECT TITLE:	SHEET CONTENT:	SHEET NO:	
	ROY RITZI A. CERVANTES	ELIZABETH S. LARASE MaEd	KAREN L. GALANIDA, PhD, CESO V	ENGR. WINABELLE R. PANGAN	ZARAGOSA NATIONAL HIGH SCHOOL	ELECTRICAL PLAN	G	
	Senior Technical Assistant II	SGOD Chief	Schools Division Superintendent	Chief, EFD	LOCATION: BRGY. ZARAGOSA, SURIGAO CITY		1	1



## LEGEND

- T ELECTRICAL TRANSFORMER
- P UTILITY POLE

**SITE PLAN**  
SCALE 1:100 M

 REPUBLIC OF THE PHILIPPINES DEPARTMENT OF EDUCATION CARAGA REGION	<b>PREPARED BY:</b>	<b>REC. APPROVAL:</b>	<b>APPROVED BY:</b>	<b>CONCURRED BY:</b>	<b>PROJECT TITLE:</b>	<b>SHEET CONTENT:</b>	<b>SHEET NO:</b>	
	ROY RITZI A. CERVANTES	ELIZABETH S. LARASE MaEd	KAREN L. GALANIDA, PhD, CESO V	 ENGR. ANNABELLE R. PANGAN	ZARAGOSA NATIONAL HIGH SCHOOL	SITE PLAN	G	
	Senior Technical Assistant II	SGOD Chief	Schools Division Superintendent	Chief, EFD	LOCATION: BRGY. ZARAGOSA, SURIGAO CITY		1	1